

CLASS/CONF. RM.

CORR.

MECH. RM.

SACRISTY

KITCHEN

CORR.

FELLOWSHIP


UTIL.

SANCTUARY

STOR.


CHOIR AREA

BY GRACE AREA

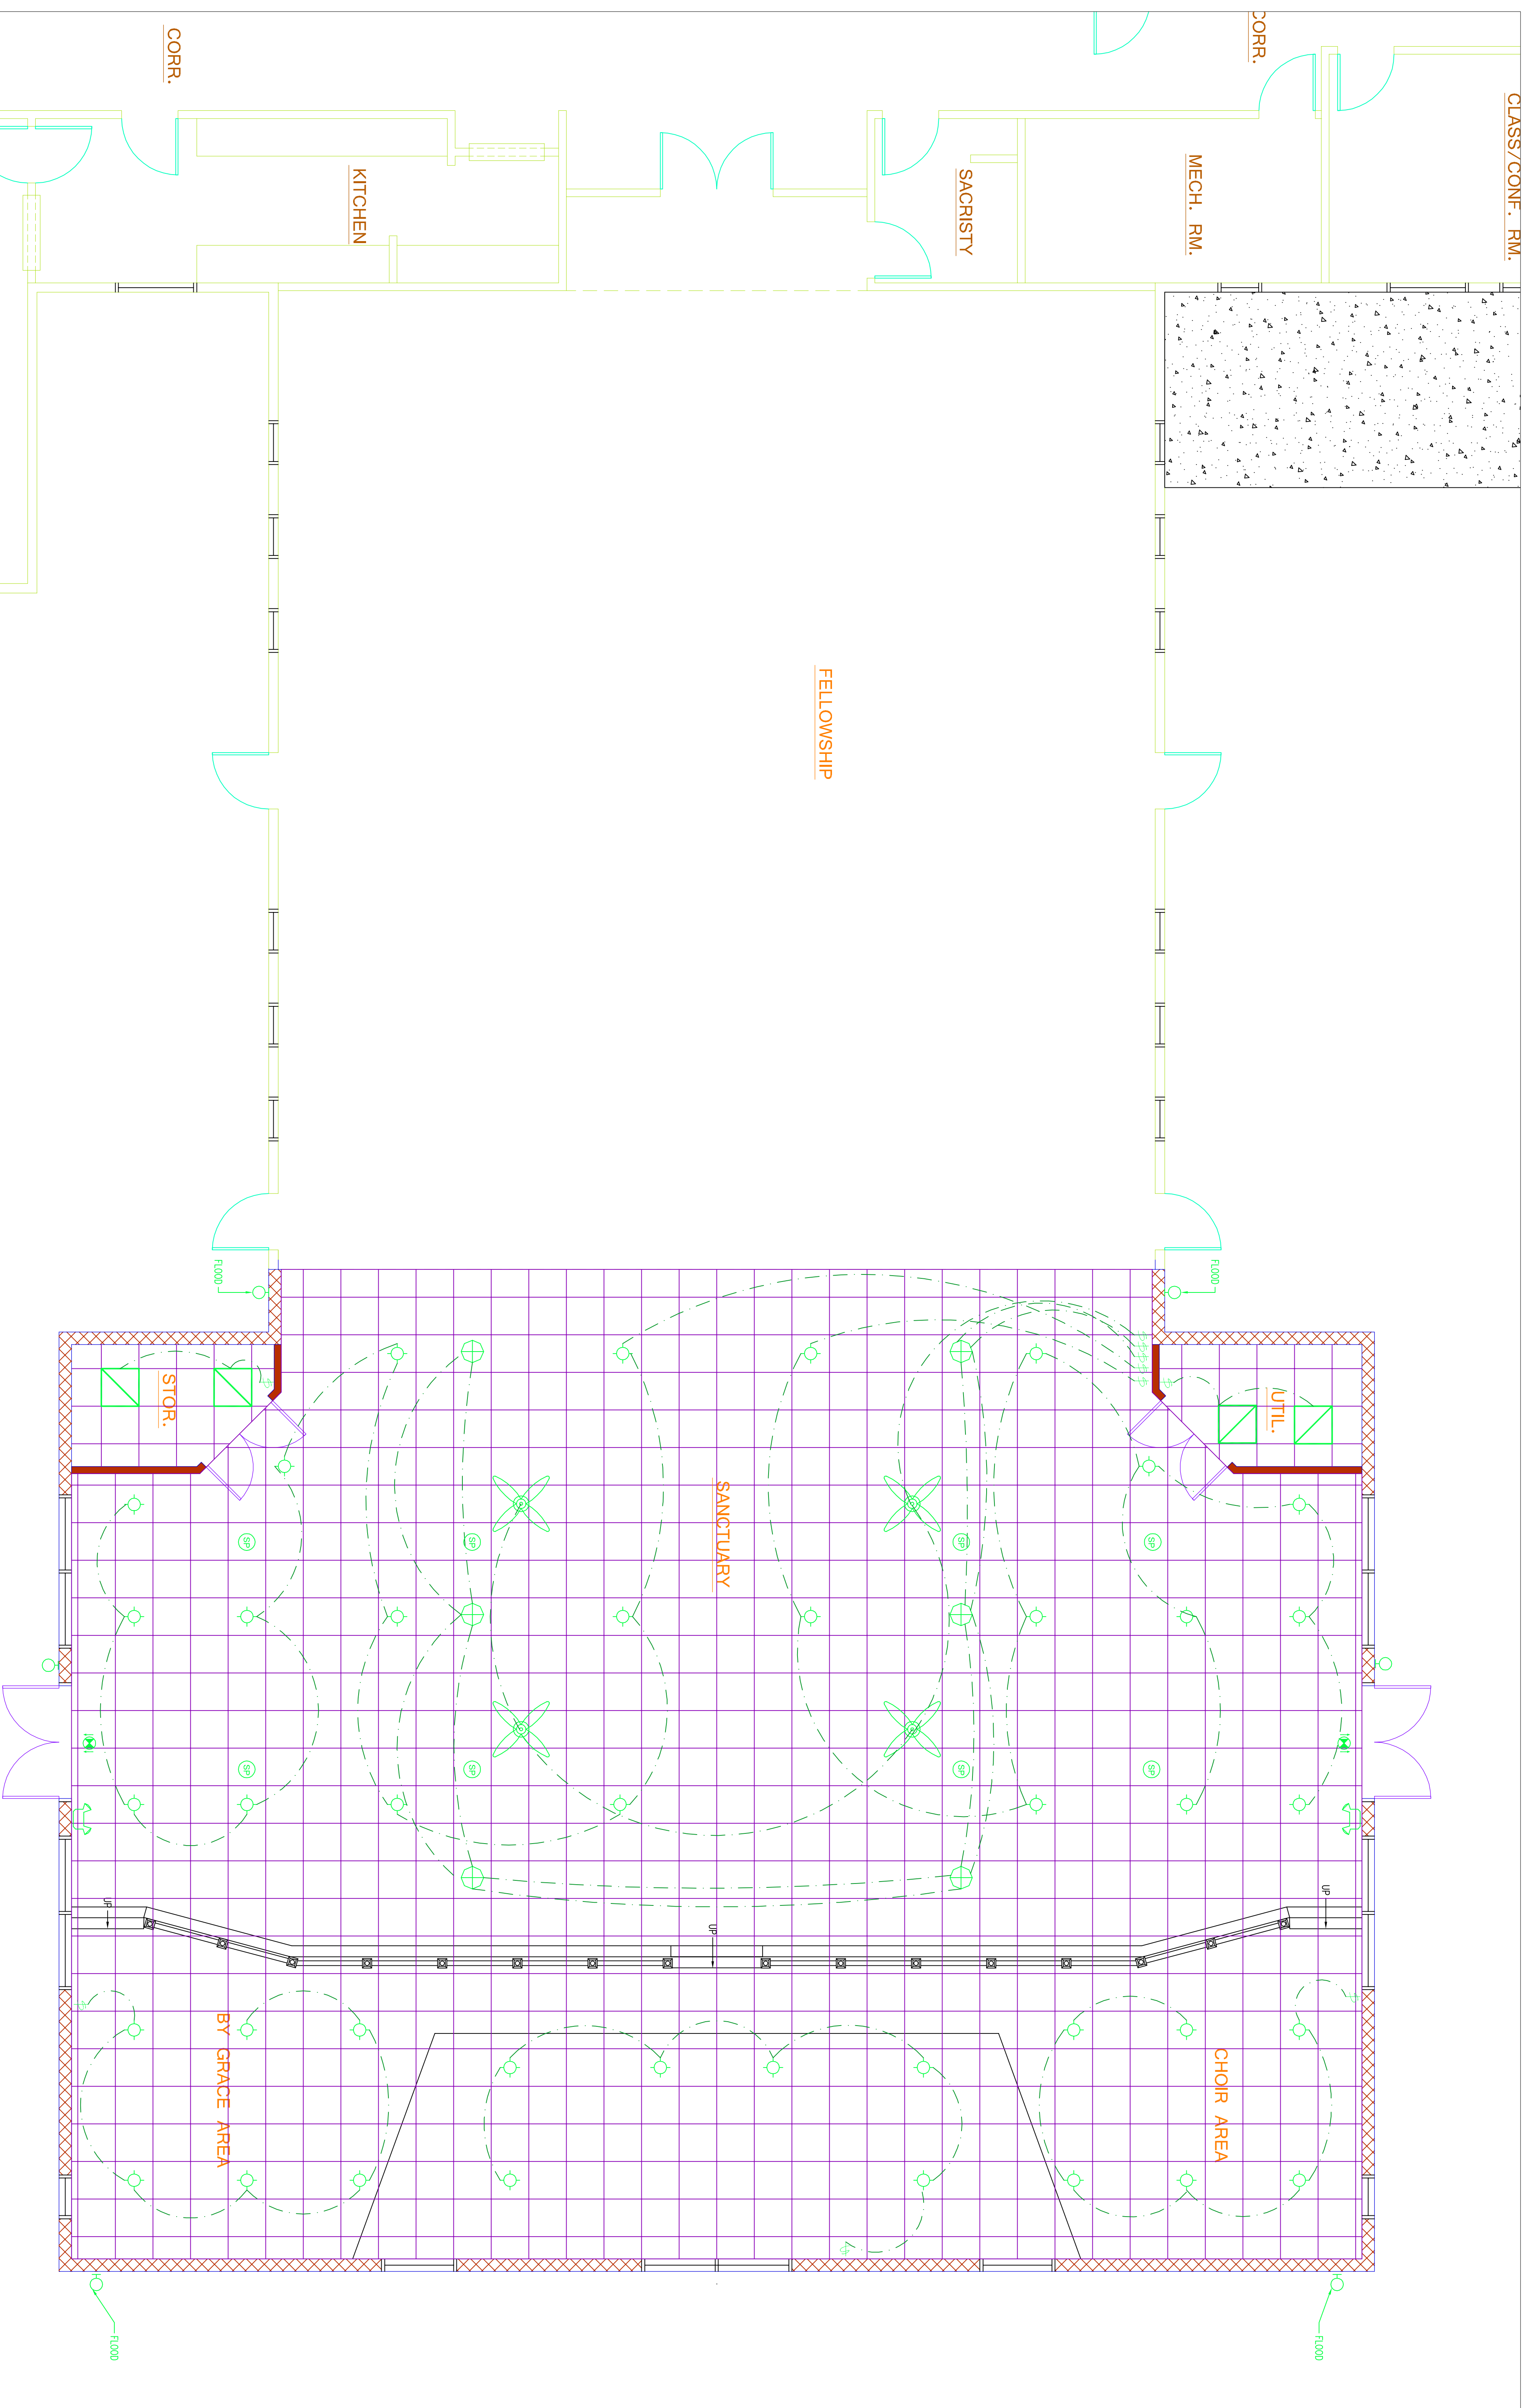

ELECTRICAL LIGHTING PLAN

1/4" = 1'-0"

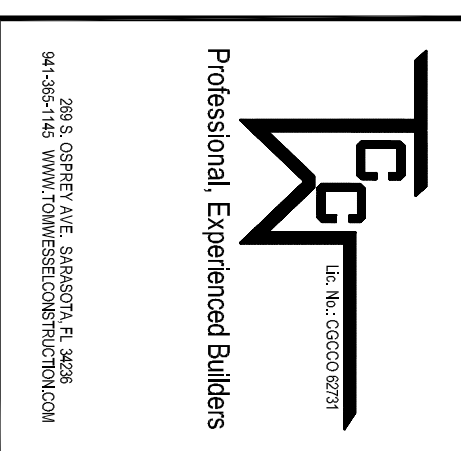

Project Information  
 LIVING LORD  
 LUTHERAN CHURCH

11120 SR 70  
 BRAEDENTON, FL 34202

Drawing Title  
 LIGHTING PLAN



OSBORN SHARP ASSOCIATES  
 2477 Stickney Point Rd.  
 Sarasota, FL 34231  
 Ph. 941.922.3506

W. T. OSBORN  
 AR - 0006998

Submittals	
Issued For	Date
<input checked="" type="checkbox"/> review	3/19/18
<input type="checkbox"/> report	
<input type="checkbox"/> use	
<input type="checkbox"/> permit	
<input type="checkbox"/> other:	

Revisions		
No	Description	Date
1	REVISED FOOTPRINT	4/1/18
2	STRUCTURAL NOTICES	4/1/18
3	MINOR CORRECTIONS	4/1/18
4	PAINTING	4/1/18
5		
6		
7		

Control	
Designed	SMH
Drawn	SMH
Checked	
Date	

Sheet No.  
**E2.0**