


CLASS./CONF. RM.

MECH. RM.

SACRISTY

KITCHEN

FELLOWSHIP

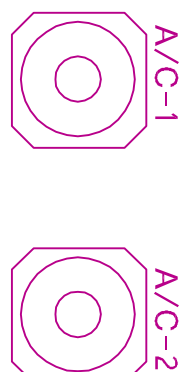

5 TN. AHU-1 5KW HT. 5 TN. AHU-2 5KW HT.

UTIL.

ZONE-2

ZONE-2

SANCTUARY

CHOIR AREA

ZONE-1

ZONE-1

ZONE-1


ZONE-3

BY GRACE AREA

STOR.

MECHANICAL/HVAC PLAN


1/4" = 1'-0"

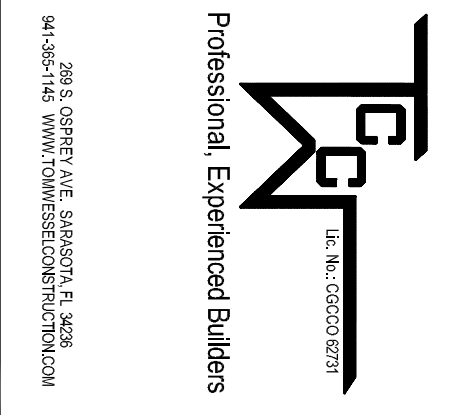

Project Information  
LIVING LORD  
LUTHERAN CHURCH

11120 SR 70  
BRADENTON, FL 34202

Drawing Title  
MECHANICAL PLAN

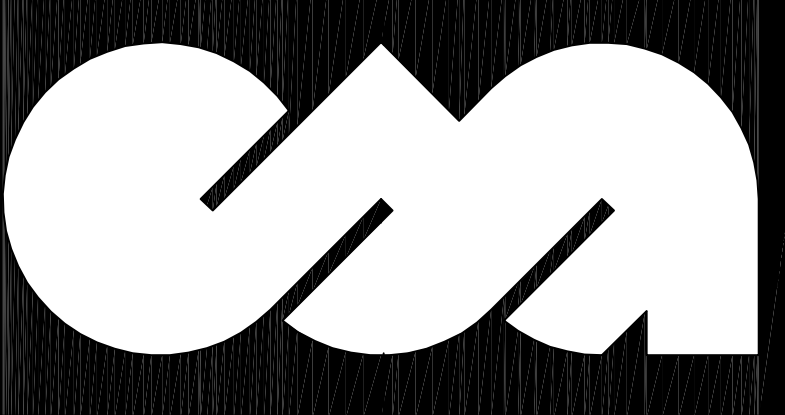

OSBORN SHARP ASSOCIATES  
2477 Stickney Point Rd.  
Sarasota, FL 34231  
Ph: 941.922.3506

W. T. OSBORN  
AR-0006998

Submittals	
Issued For	Date
<input type="checkbox"/> material	• 3/19/18
<input type="checkbox"/> report	•
<input type="checkbox"/> use	•
<input type="checkbox"/> permit	•
<input type="checkbox"/> other:	•

Revisions		
No	Description	Date
1	PERMISS FOOTPRINT	• 4/1/18
2	STENCIL ROOMS	• 4/1/18
3	RELOCATIONS	• 4/1/18
4	PAINTS	• 4/1/18
5		•
6		•

Control	
Designed	• SMH
Drawn	•
Checked	•
Date	•

Sheet No.  
M1.0